


SITE LOCATION

DRAFTING NOTES


- 1. THIS DRAWING IS THE COPYRIGHT OF THE BARBADOS WATER AUTHORITY AND MUST NOT BE RETAINED, COPIED OR USED WITHOUT THE ABOVE COMPANY'S AUTHORITY.
- 2. ALL DIMENSIONS ARE IN METERS UNLESS NOTED OTHERWISE.

TECHNICAL NOTES


LEGEND

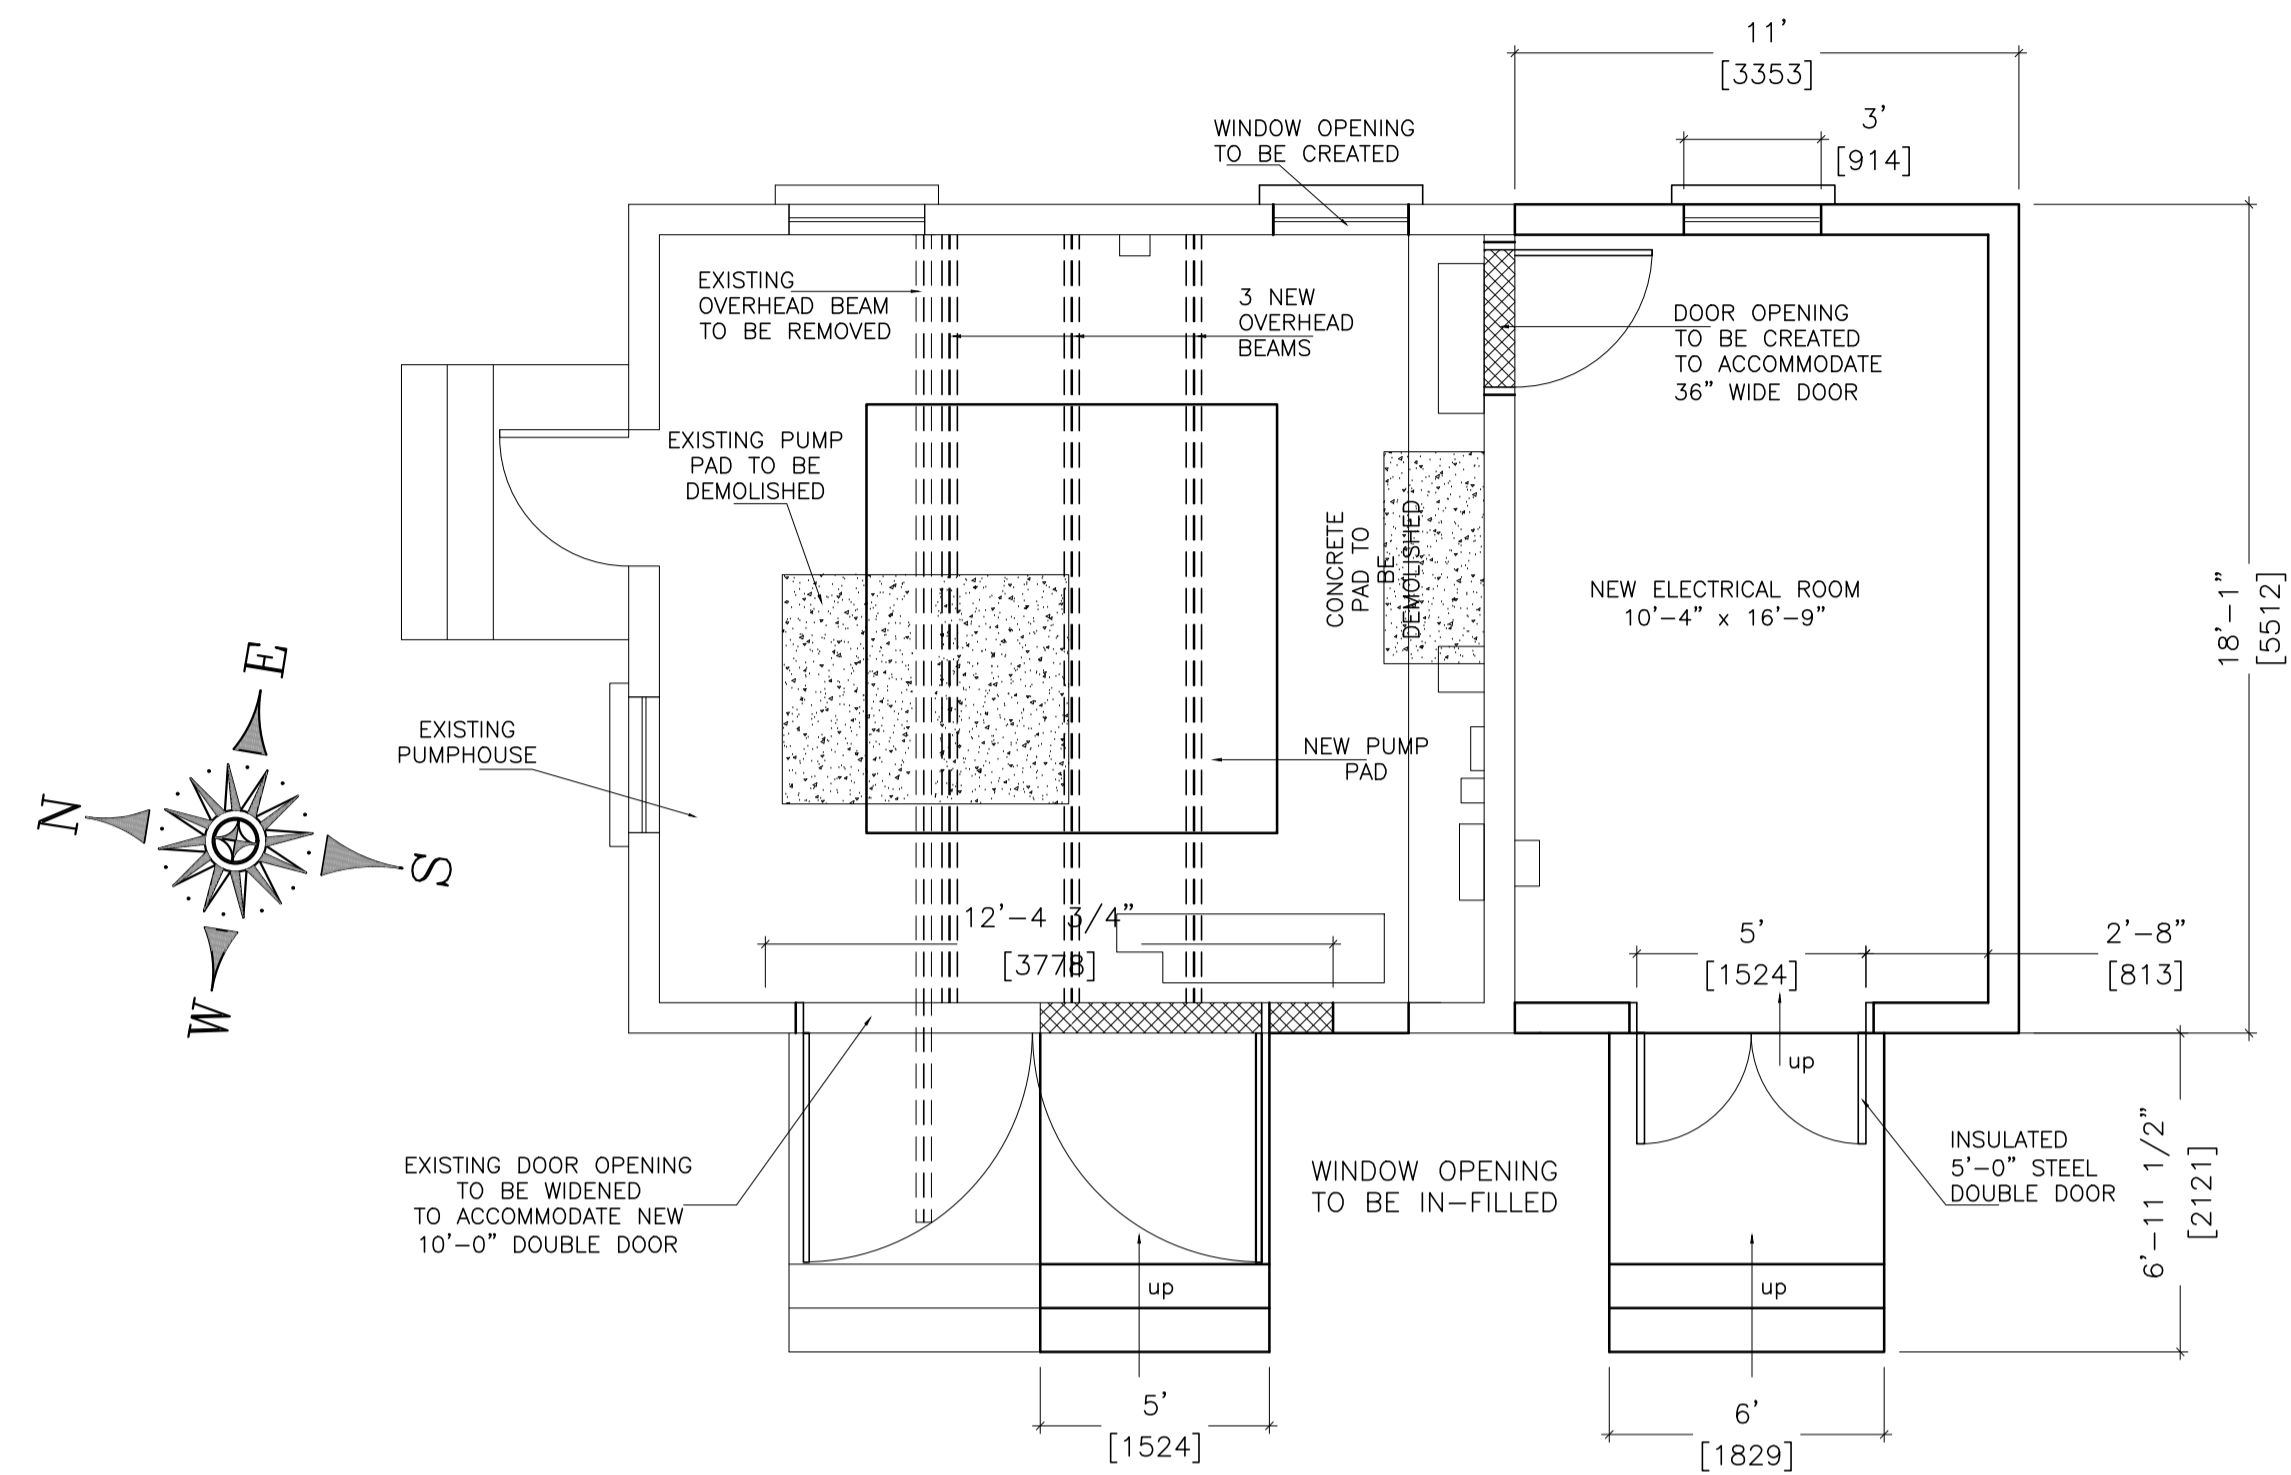

GENERAL ARRANGEMENT PLAN
SCALE 1:50

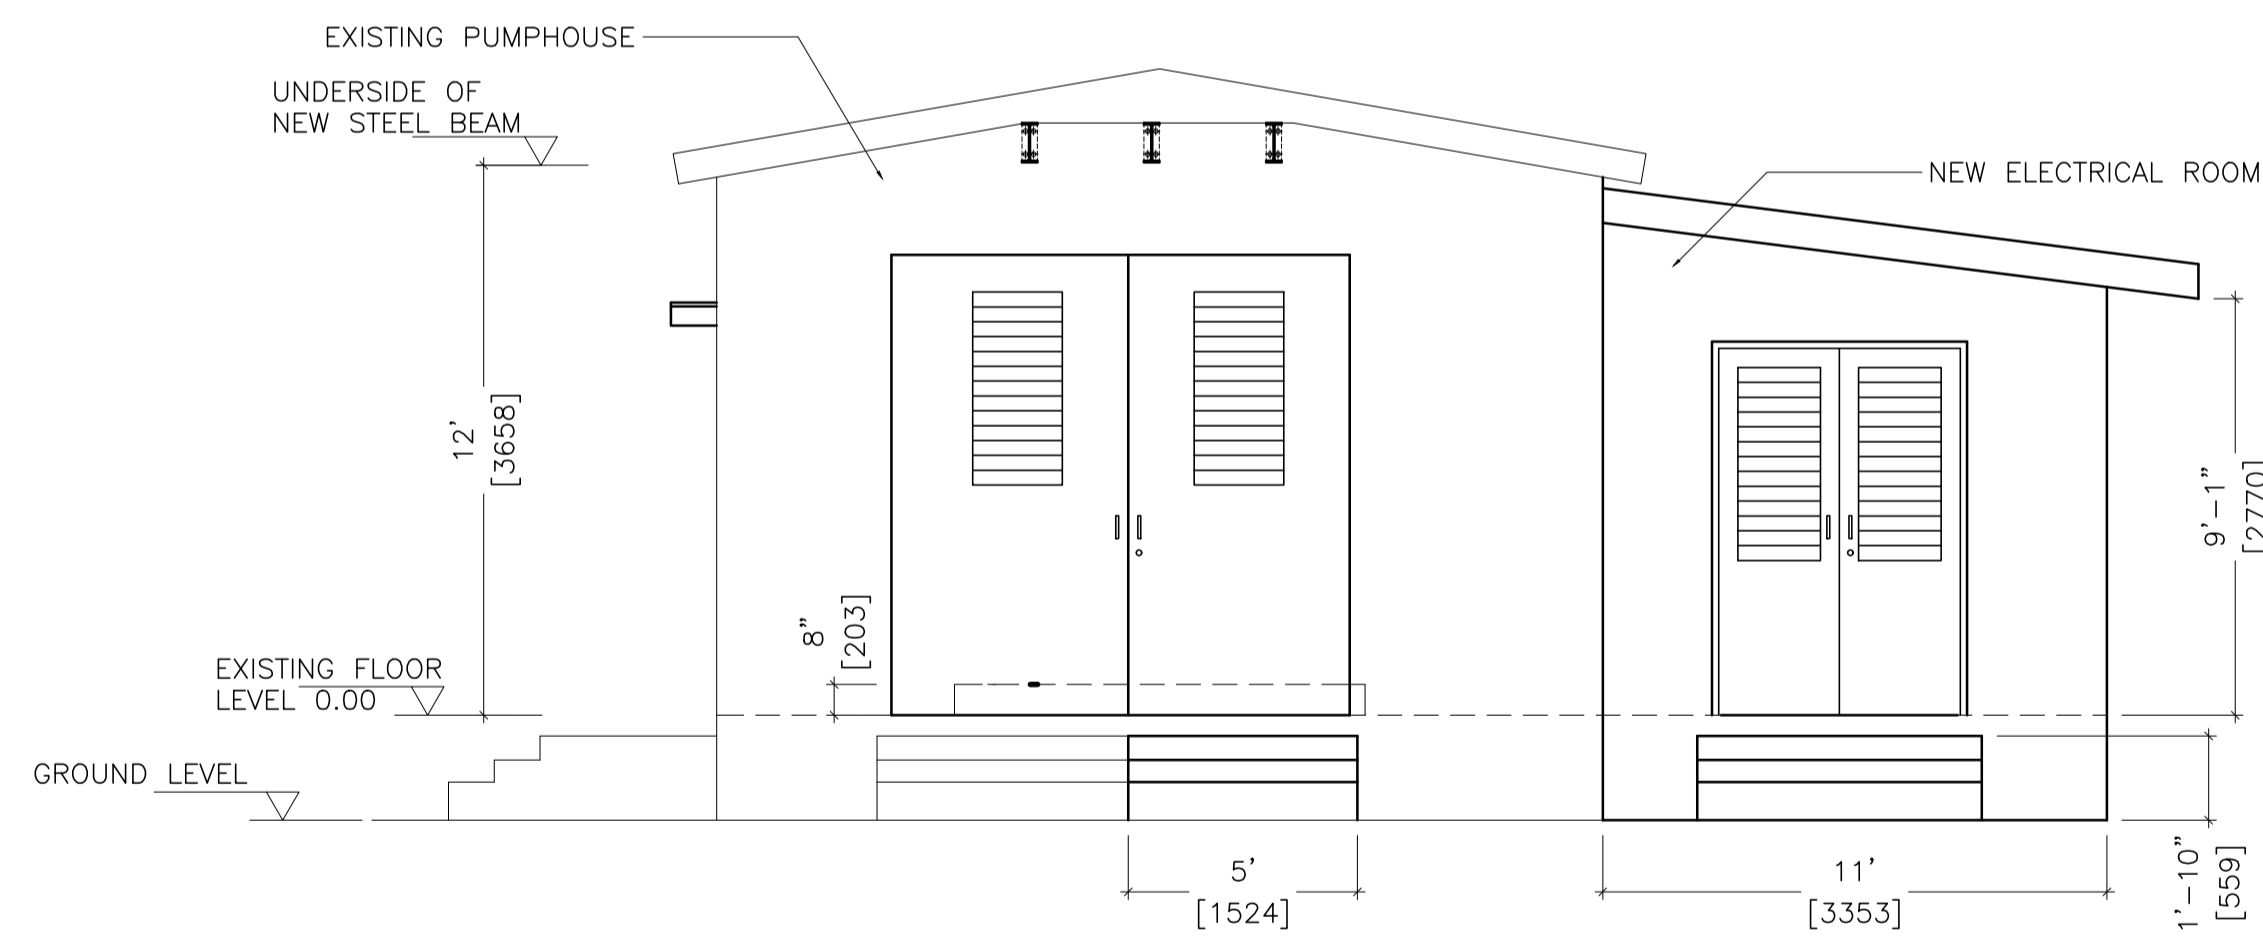

WEST ELEVATION
SCALE 1:50

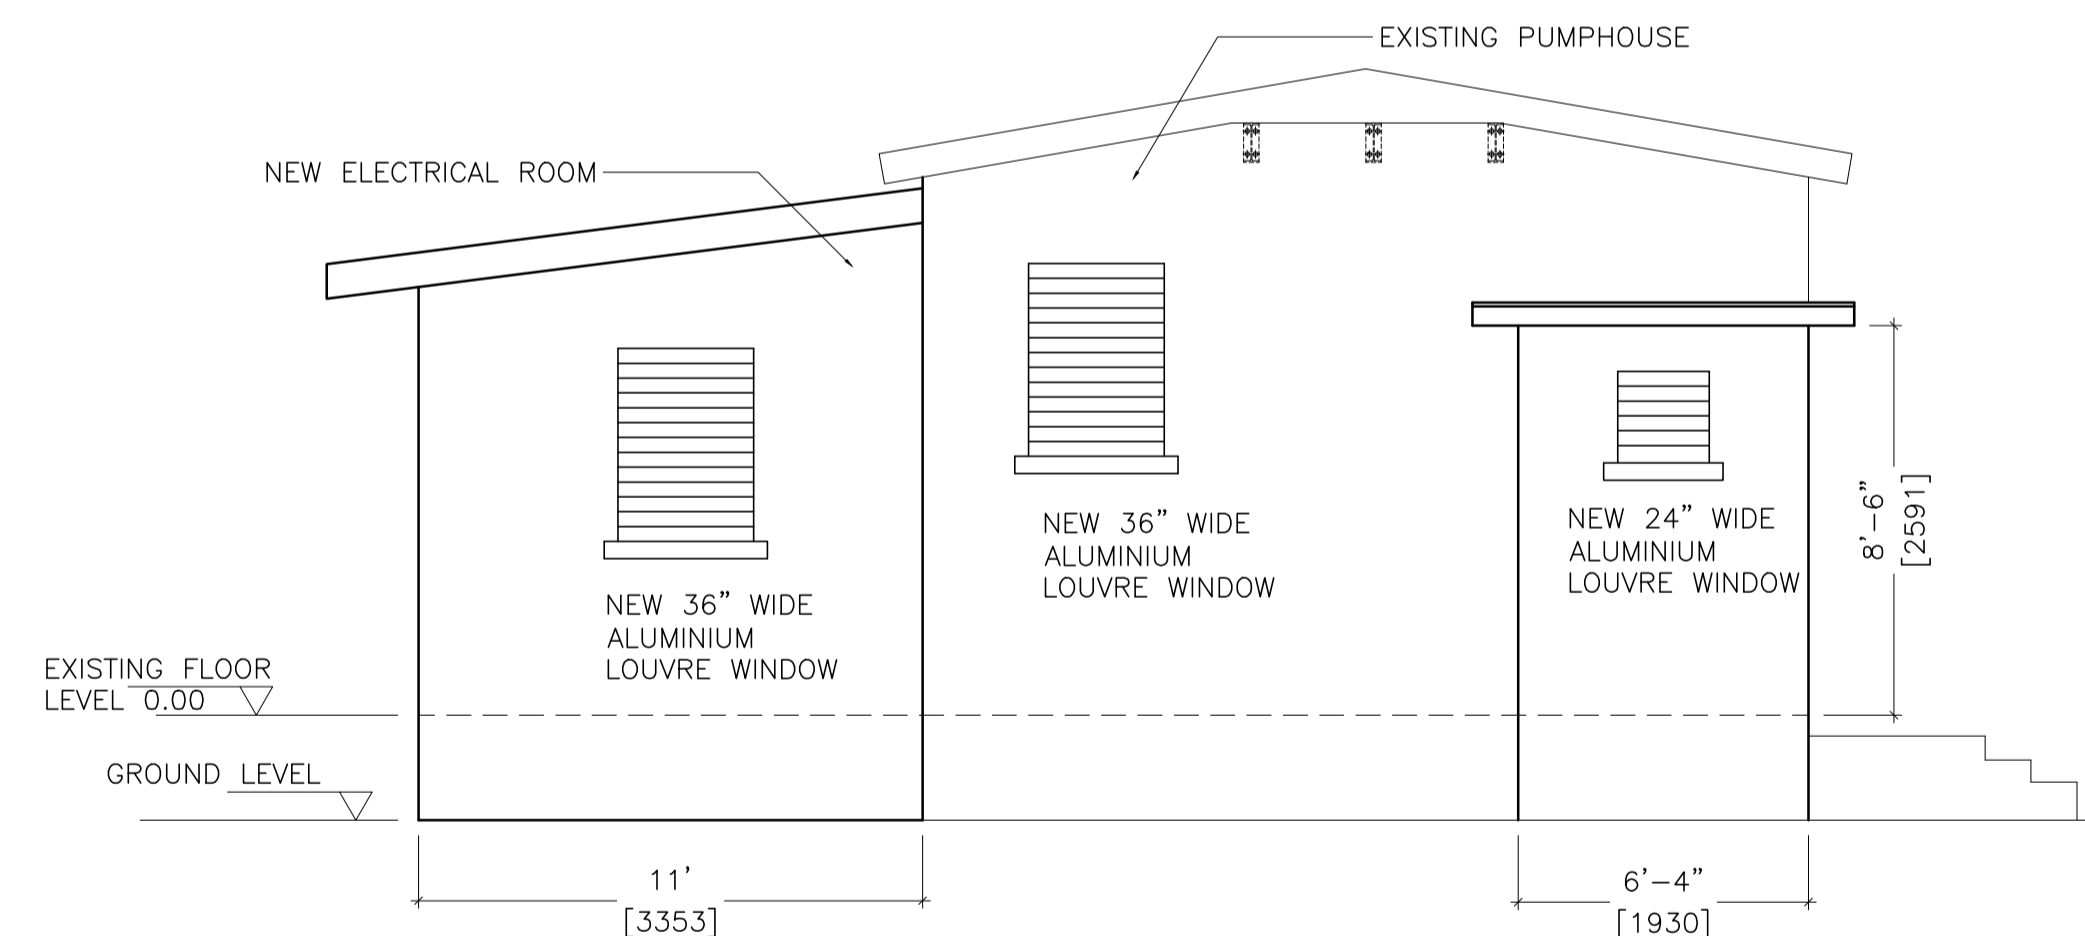

EAST ELEVATION
SCALE 1:50

REV	DESCRIPTION	DATE	DRAWN BY	STATUS
0	ISSUED FOR REVIEW	10 NOVEMBER 2020	RG	-----
1	ISSUED FOR TENDER	16 MARCH 2021	RG	
---	---	---	---	
---	---	---	---	
---	---	---	---	



BARBADOS WATER AUTHORITY
GOVERNMENT OF BARBADOS

PINE COMMERCIAL ESTATE, PINE ST. MICHAEL, BARBADOS
TEL: (246) 434-4200
FAX: (246) 426-4507

PROJECT NAME :	LANCASTER PUMPING STATION UPGRADE & EXPANSION LANCASTER , ST. JAMES
PROJECT ID :	
CLIENT :	

SHEET NAME :	GENERAL ARRANGEMENT PLAN & ELEVATIONS	
DESIGNED BY :		DATE : 16 MARCH 2021
DRAWN BY :		SHEET : GA2
REVIEWED BY :		